


Cromwell Road

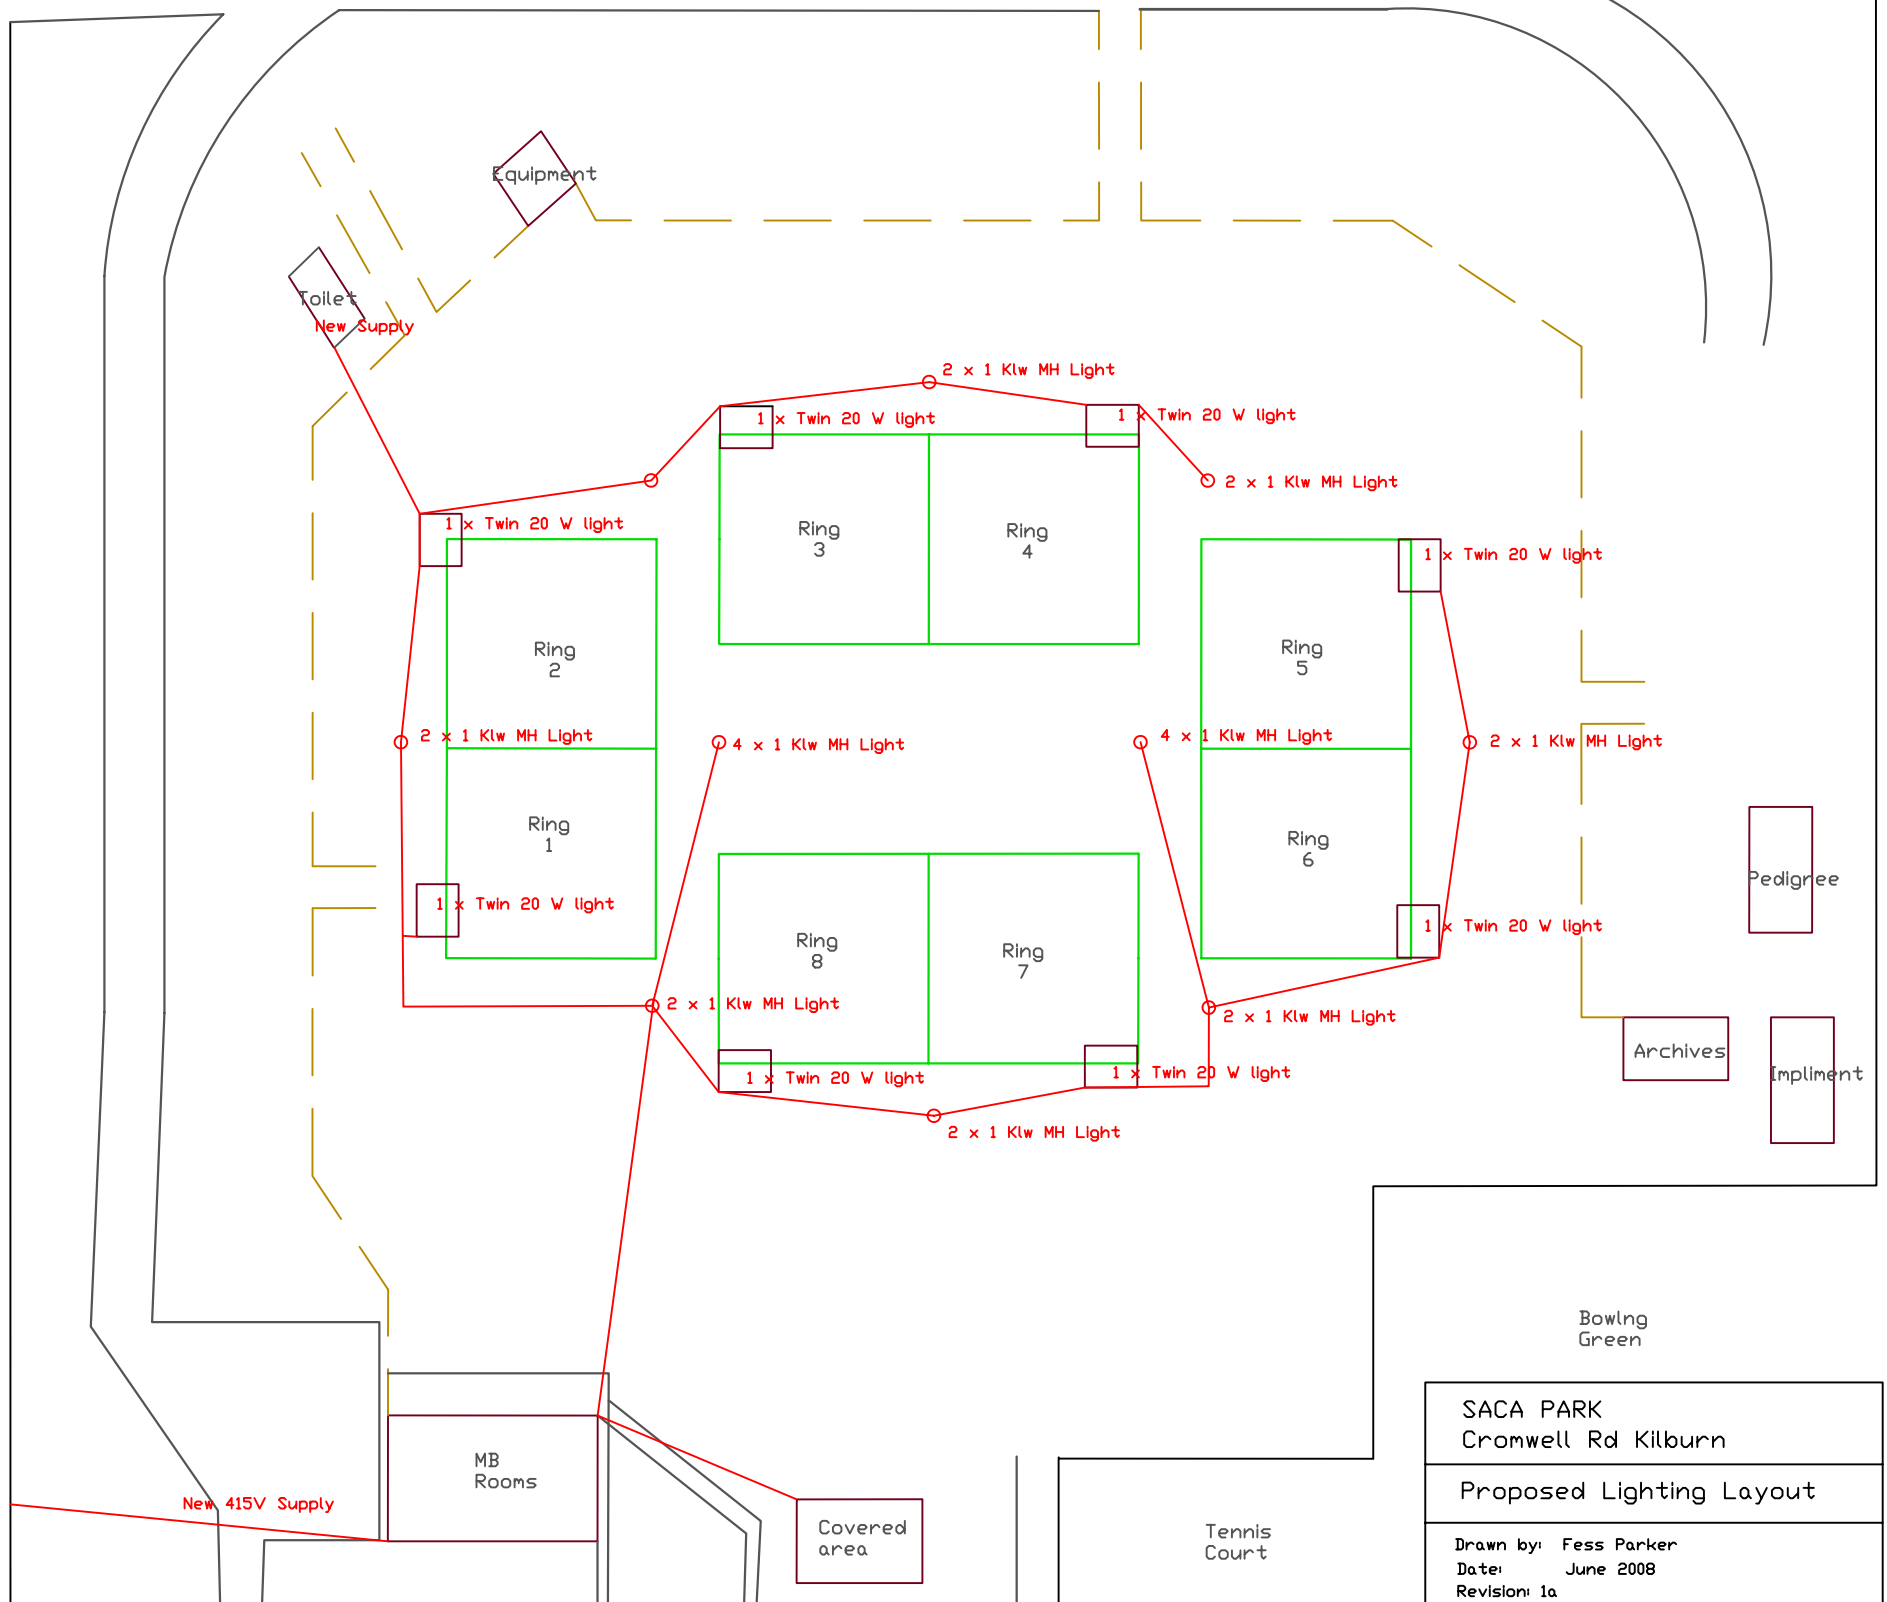

SACA PARK Cromwell Rd Kilbourn
Proposed Lighting Layout
Drawn by: Fess Parker Date: June 2008 Revision: 1a